


SCHEDULE OF ELEVATIONS

LOCATION	TOP	GRADE	INFLUENT	ALARM	LAG PUMP ON	LEAD PUMP ON	BOTH PUMPS OFF	BOTTOM	WET WELL DIA	WET WELL H
MEADOW SWEET LANE	22.55	B	C	D	E	F	G	3.69	H	I
12785 MEADOWSWEET LN.										

FOR ROCK EPOXY LINED, TOP OF CONCRETE TO BE OF CONCRETE, CENTERED WITH HATCH OPENING, CENTERED ON PUMPS, CONCRETE AND REIN- FORCING TO BE CERTIFIED BY A FLORIDA REGISTERED ENGINEER.


ALUMINUM CHECKER PLATE HATCH COVER CAST IN TOP SLAB WITH CAST ALUM DRAIN HANDLE AND STAIN- LESS STEEL HARDWARE.

X REDESTIANE: LOADING (OR) H-20 TRAFFIC LOADING, APPROVED EQUAL.

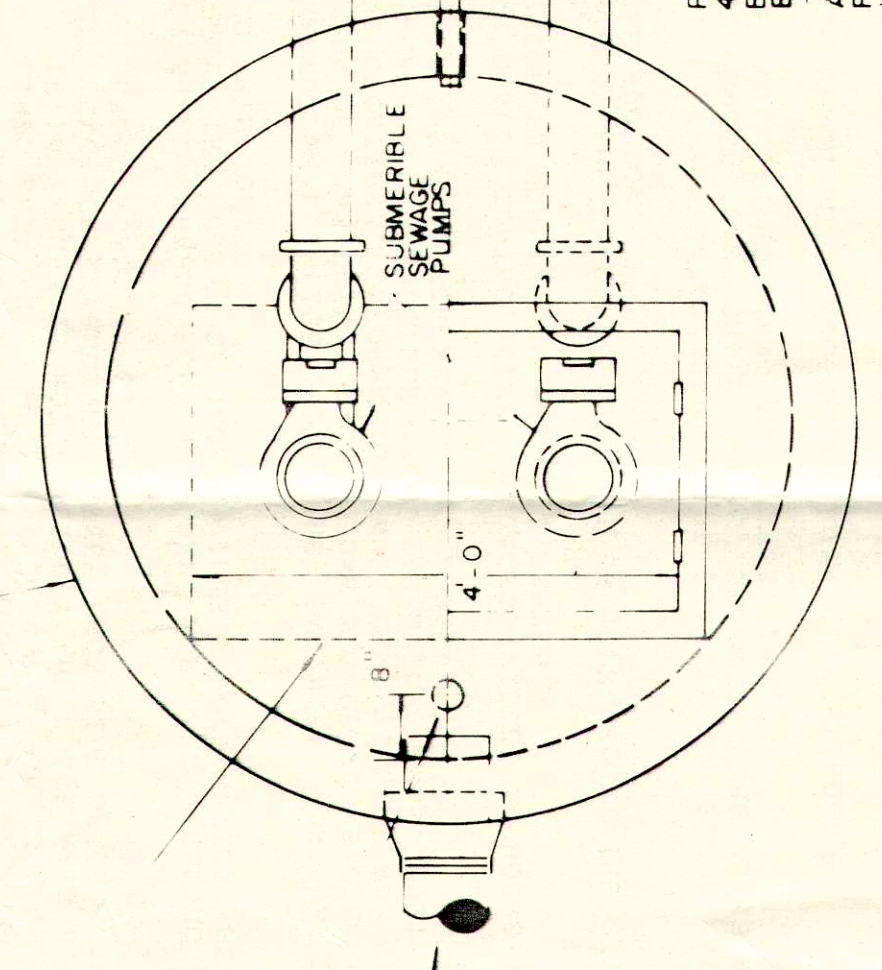


WETWELL TOP VIEW
N.T.S.

VALVE BOX
PLAN VIEW

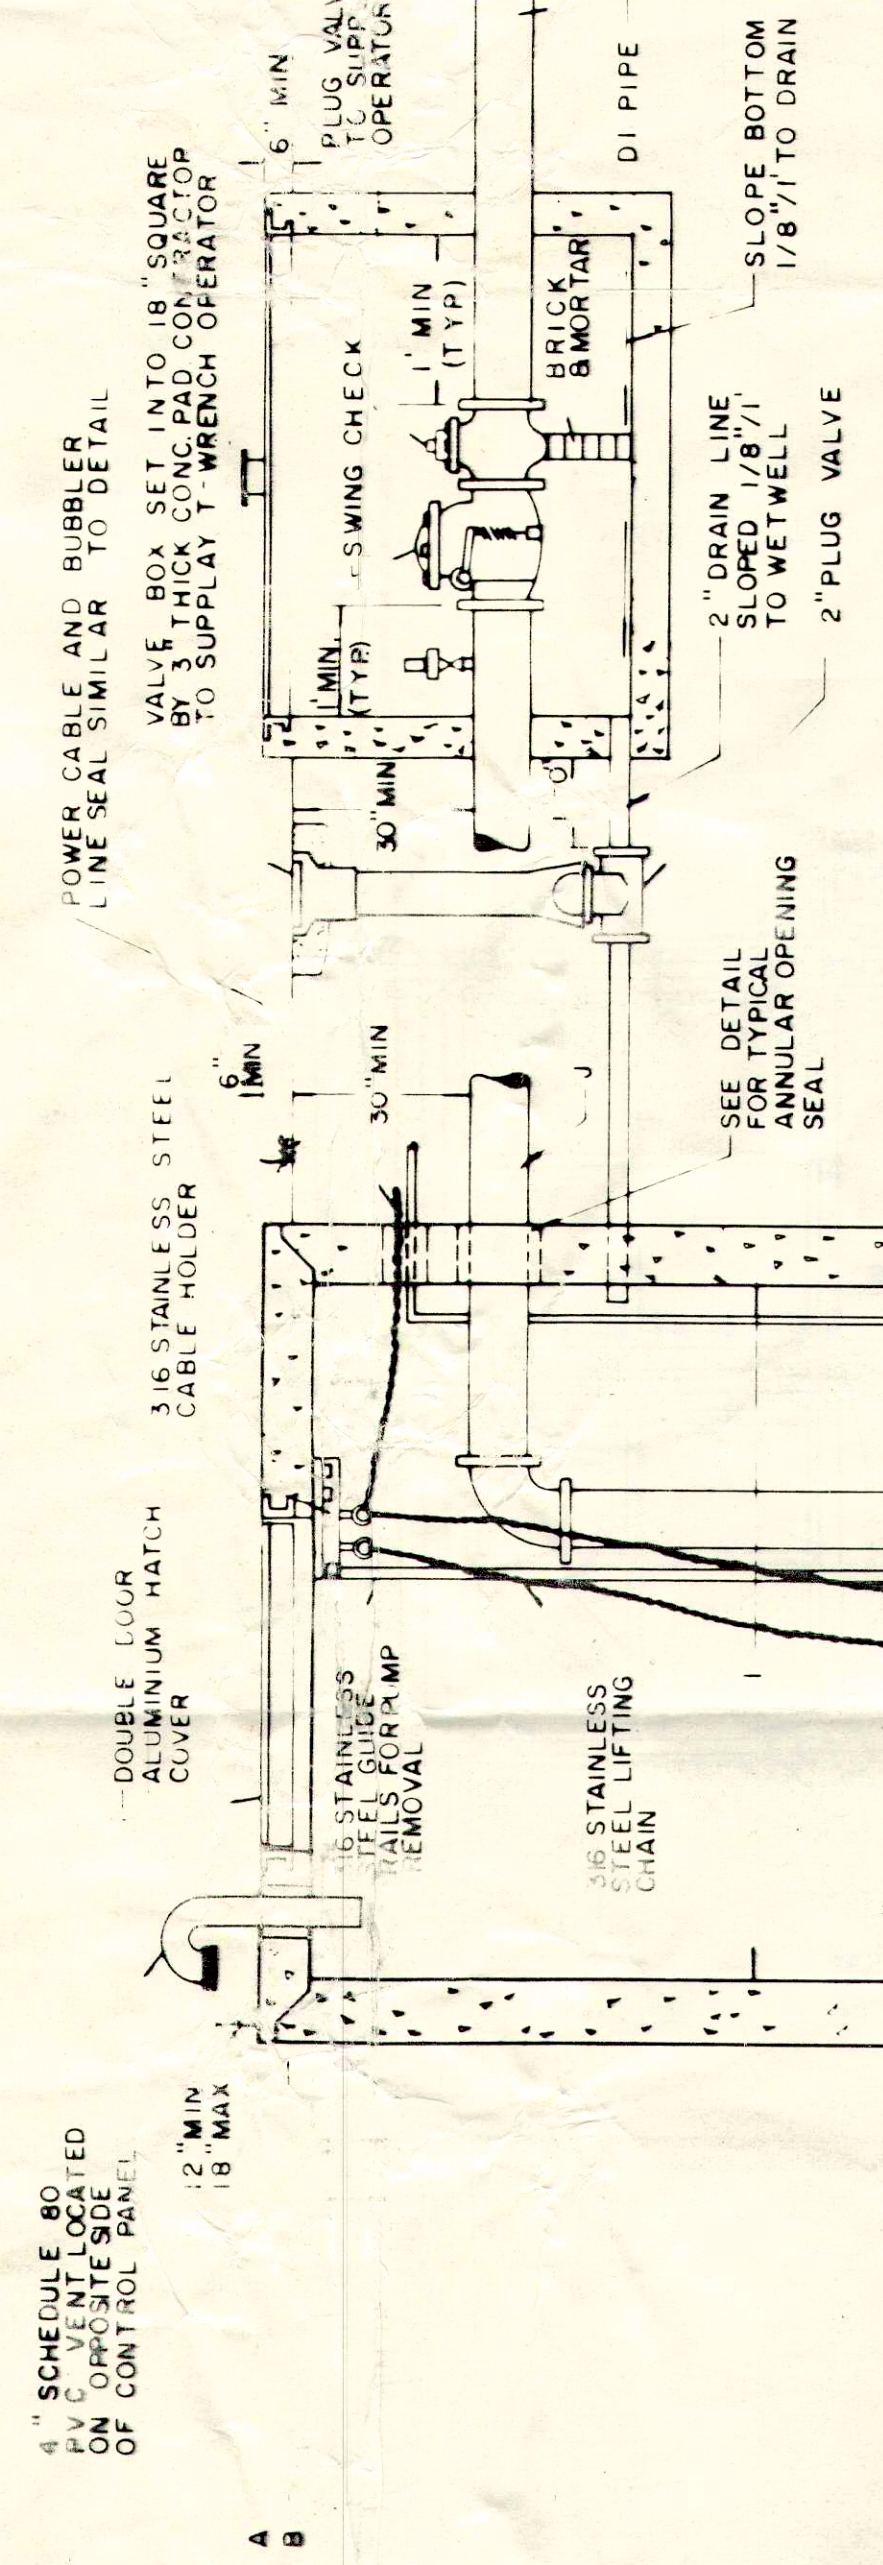


VALVE BOX
SIDE VIEW

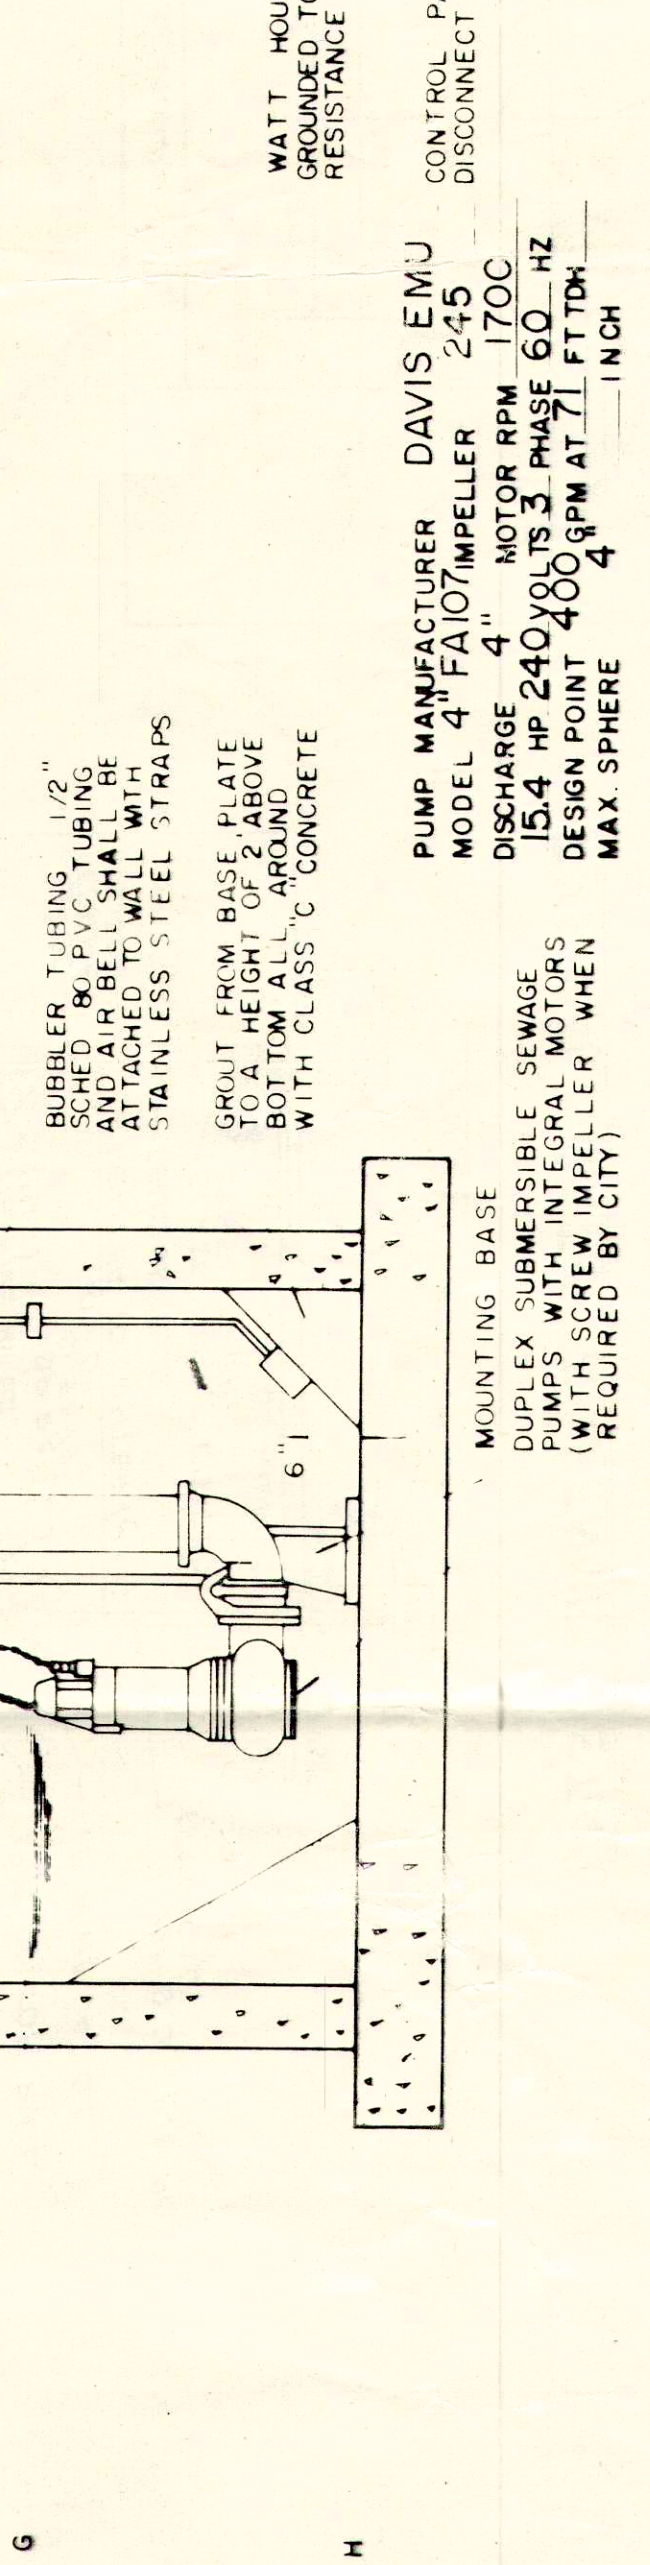


WETWELL ELEVATION
N.T.S.

WATER SERVICE
N.T.S.

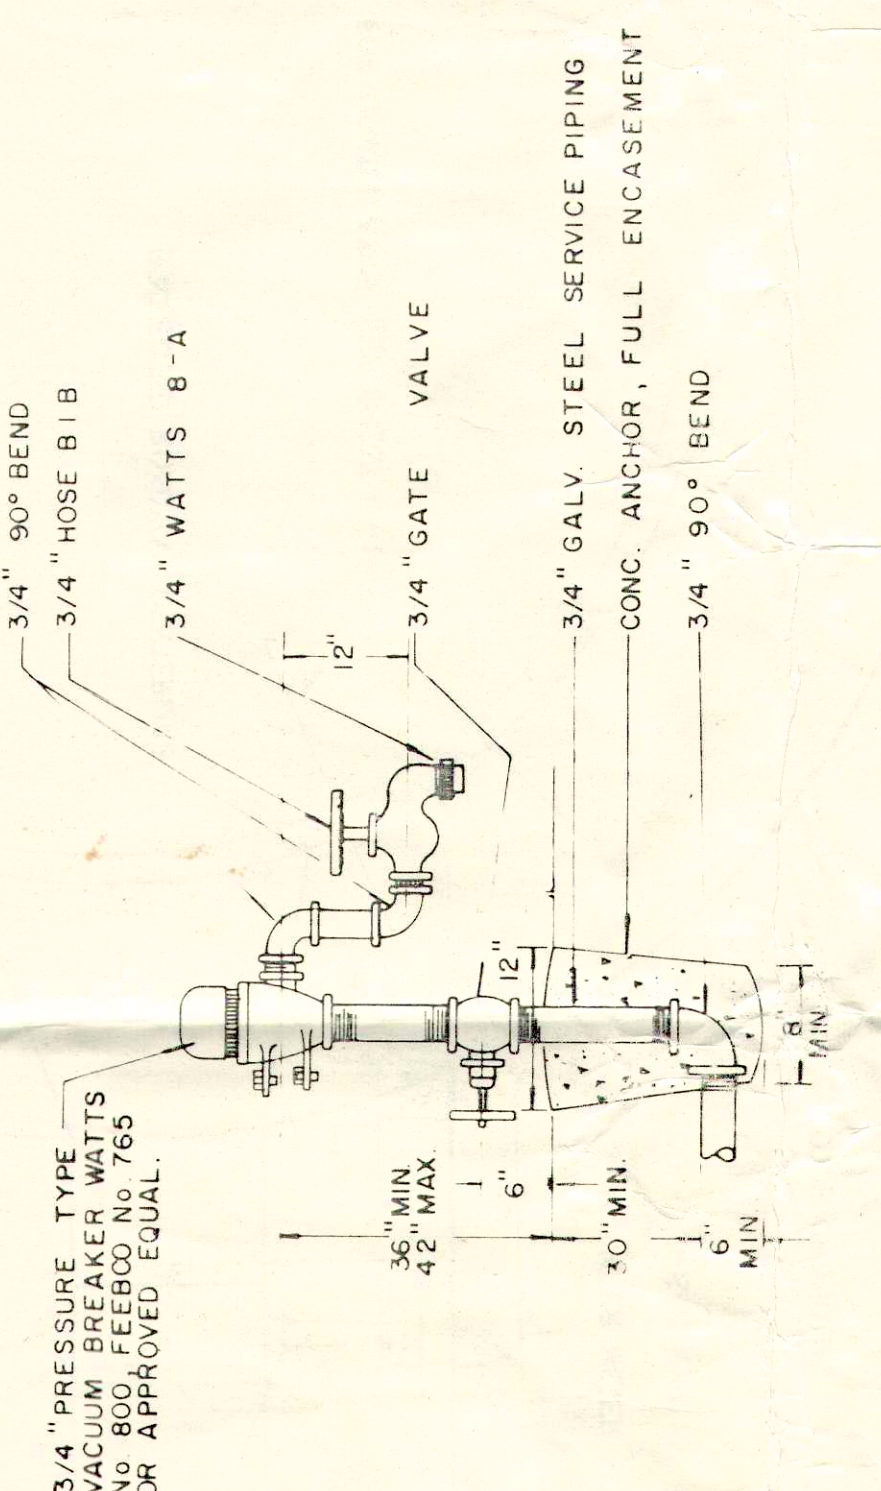


NOTE: CONTRACTOR TO INSTALL SERVICE PIPING, WATER METER, AND UTILITY POLE. APPLICATION AND FEES BY CONTRACTOR.

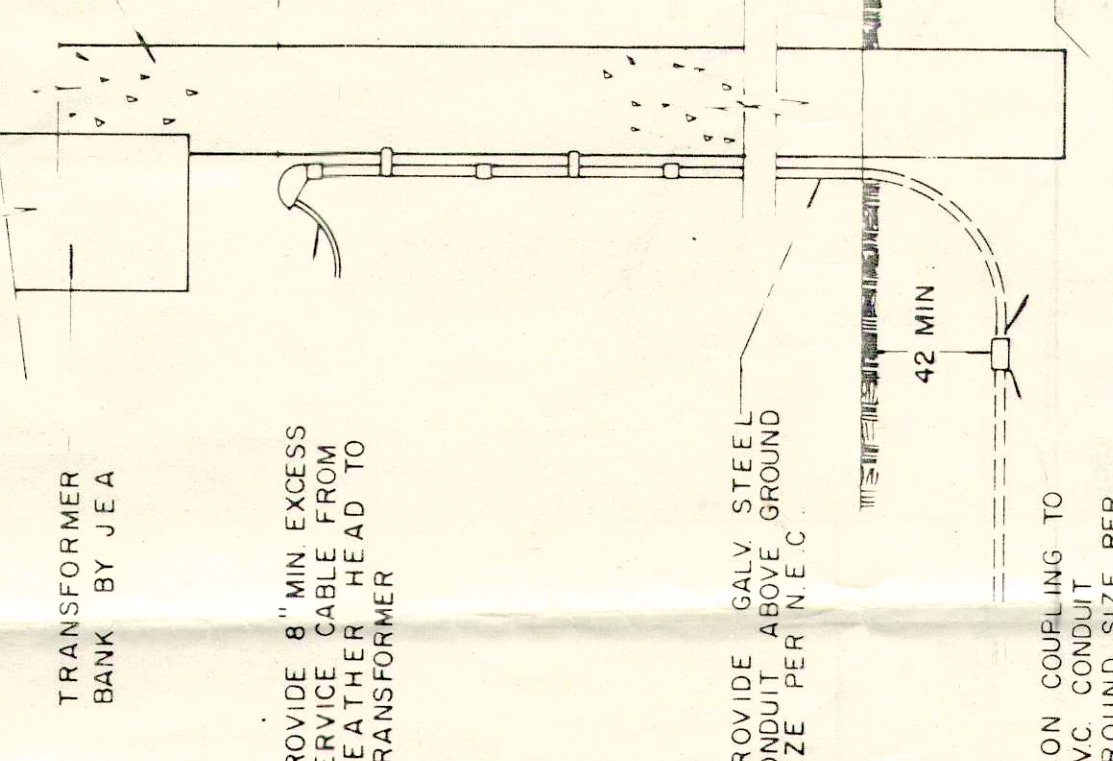

POWER RISER
DETAIL
N.T.S.

LOW PROFILE CONTROL
PANEL

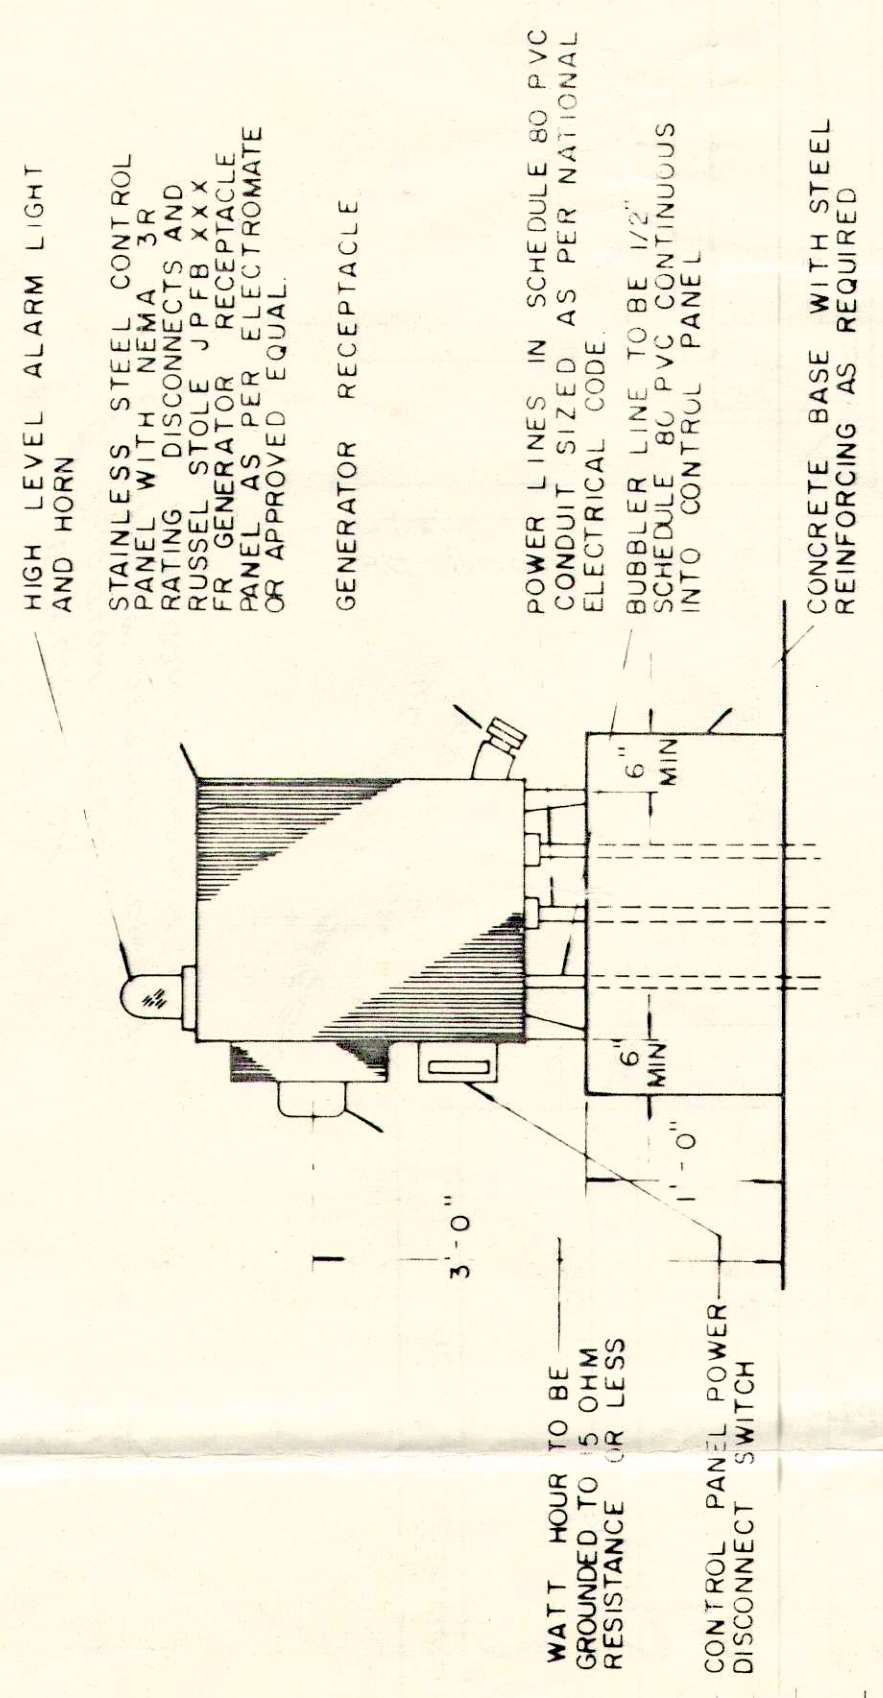

*** AS-BUILT**

TOP EL. 22.55
GRADE EL. 22.05
INT. EL. 9.63
BOT. EL. 3.69

ALL AMERICAN SURVEYORS, INC.

LAND SURVEYORS - 4200 HODD ROAD - JACKSONVILLE, FLORIDA 32217 - 904/284-4155

I HEREBY CERTIFY THAT THE ABOVE LANDS WERE SURVEYED UNDER MY PERSONAL SUPERVISION AND THAT THE SURVEYING INSTRUMENTS AND ENFORCEMENTS EXCEPT AS SHOWN AND THAT THE SURVEY SHOWN HEREON MEETS THE MINIMUM TECHNICAL STANDARDS SET FORTH BY THE FLORIDA STATUTES AND THE SURVEYORS' ACT AND THE SURVEYORS' ACT, FLORIDA STATUTES.

JAMES O. HARRISON, JR. L.S. No. 2047
James O. Harrison, Jr.
REGISTERED SURVEYOR (STATE OF FLORIDA)

SCALE 3/16"=1'-0"
DATE

AS-BUILT

THIS AS-BUILT DRAWING HAS BEEN REVIEWED AND I AGREE THAT IT REPRESENTS THE ACTUAL FIELD LOCATION OF UTILITIES.

DATE: 3-10-14
BY: David R. H. DATE: 3-10-14
WITH: DW. HARRISON, JR., P.E.

HICKORY CREEK FOR HICKORY CREEK JOINT VENTURE

J. LUCAS & ASSOC., INC.
CONSULTING AND DESIGN ENGINEERS
JACKSONVILLE, FLORIDA

DATE: 3-10-14
DESIGNED BY: J.L.
DRAWN BY: J.L.
CHECKED BY: J.L.
PROJECT NO.: 37